



PLOT DATE: August 21, 2023 - U:\117076\110_drawing\02_sheets\01_civil\01_DWG\75%_DESIGN REVIEW\100 - OVERALL SITE PLAN.dwg

NO.	DATE	REVISION	DRAWN	APPR'D
1	08-22-2023	ISSUED FOR 75% DESIGN REVIEW	MB	AH



Stantec
 4515 Central Blvd. #500
 Burnaby, BC Canada V5H 0C6
 Tel: (604) 436-3014
 www.stantec.com


DRAWN	MBB
DESIGNED	LP
CHECKED	CC
APPROVED	AH
SCALES	
HORZ.	1:200
VERT.	1:200

NOT FOR CONSTRUCTION
 Not for permits, pricing or other official purposes. This document has not been completed or checked and is for general information or comment only.


DISTRICT OF WEST VANCOUVER
 ENGINEERING DEPARTMENT

OVERALL SITE PLAN
 11TH STREET PUMP STATION REPLACEMENT
 #1075 MATHERS AVE WEST VANCOUVER, BC

DATE	JULY 2023
SHEET	OF
DWG. No.	C100

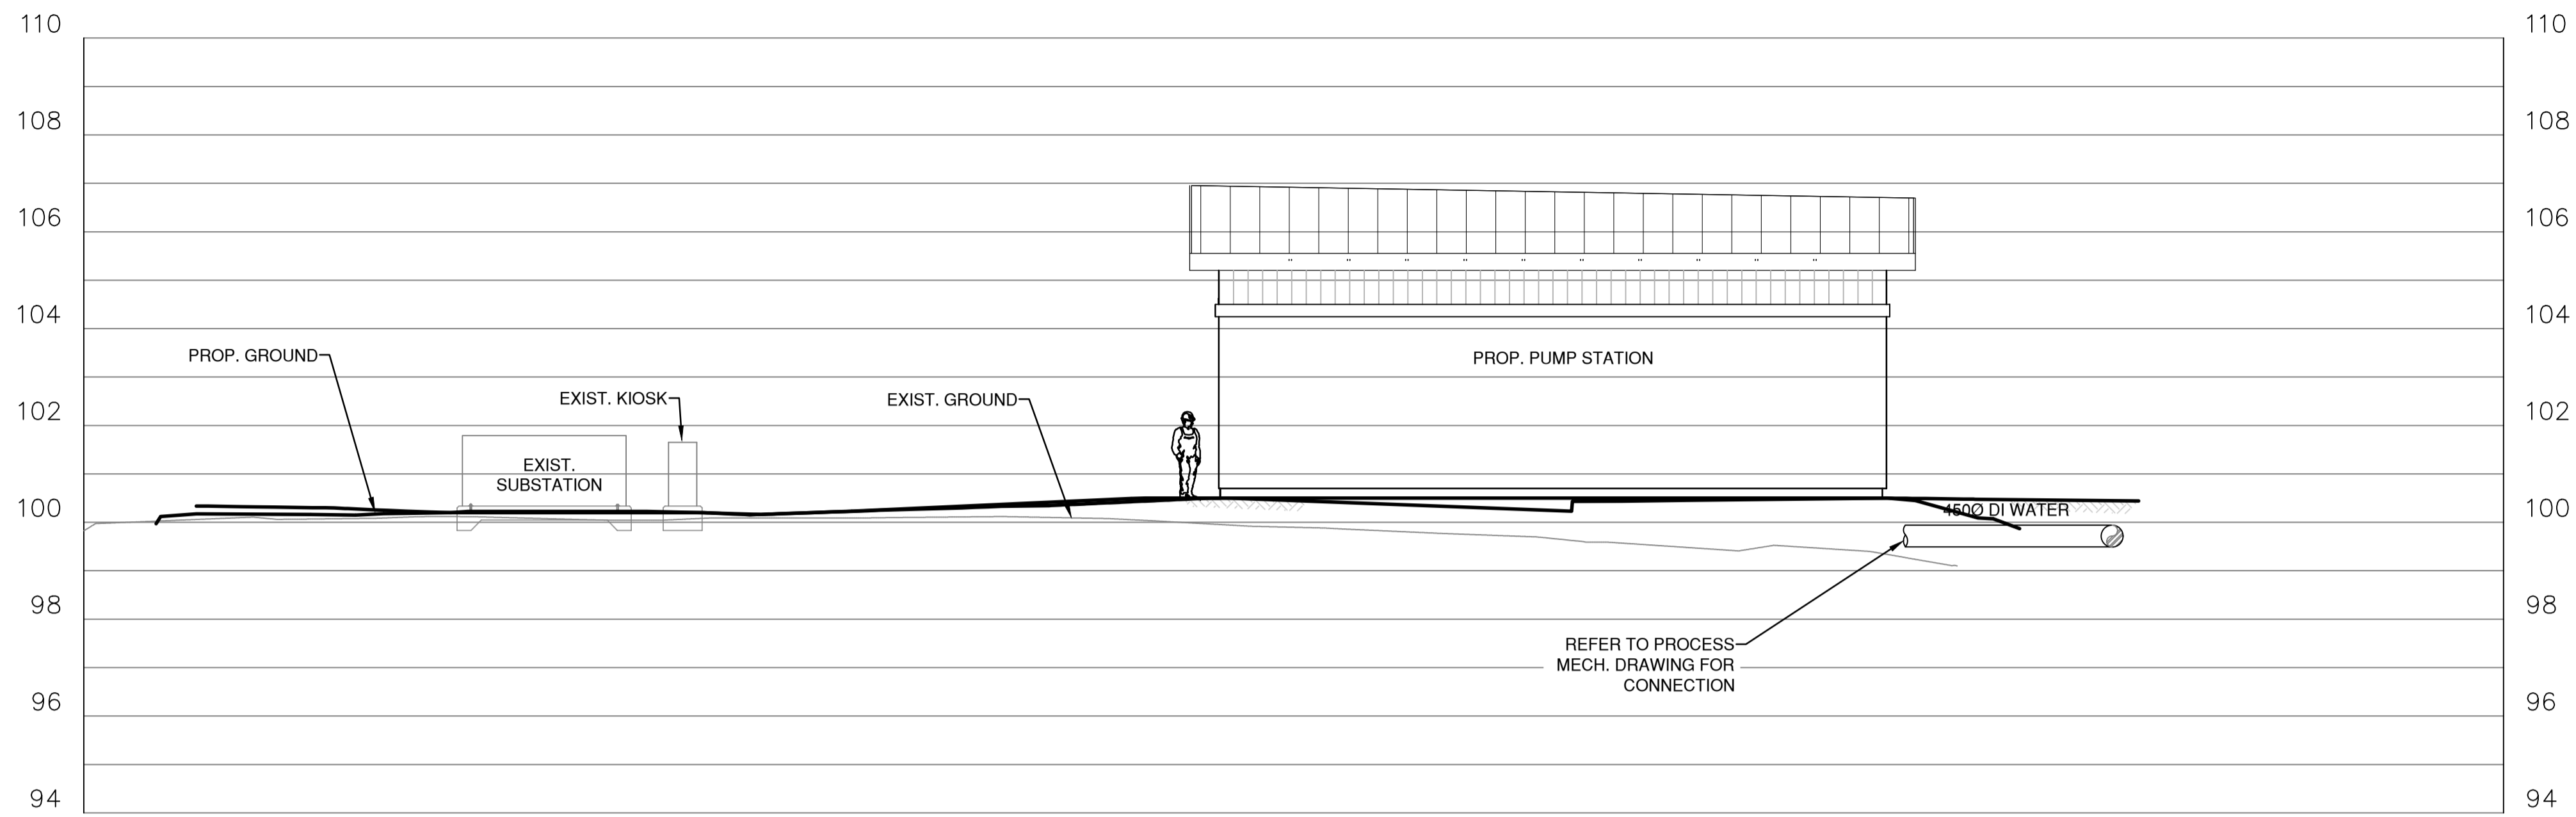

1 SECTION
C101 1:100

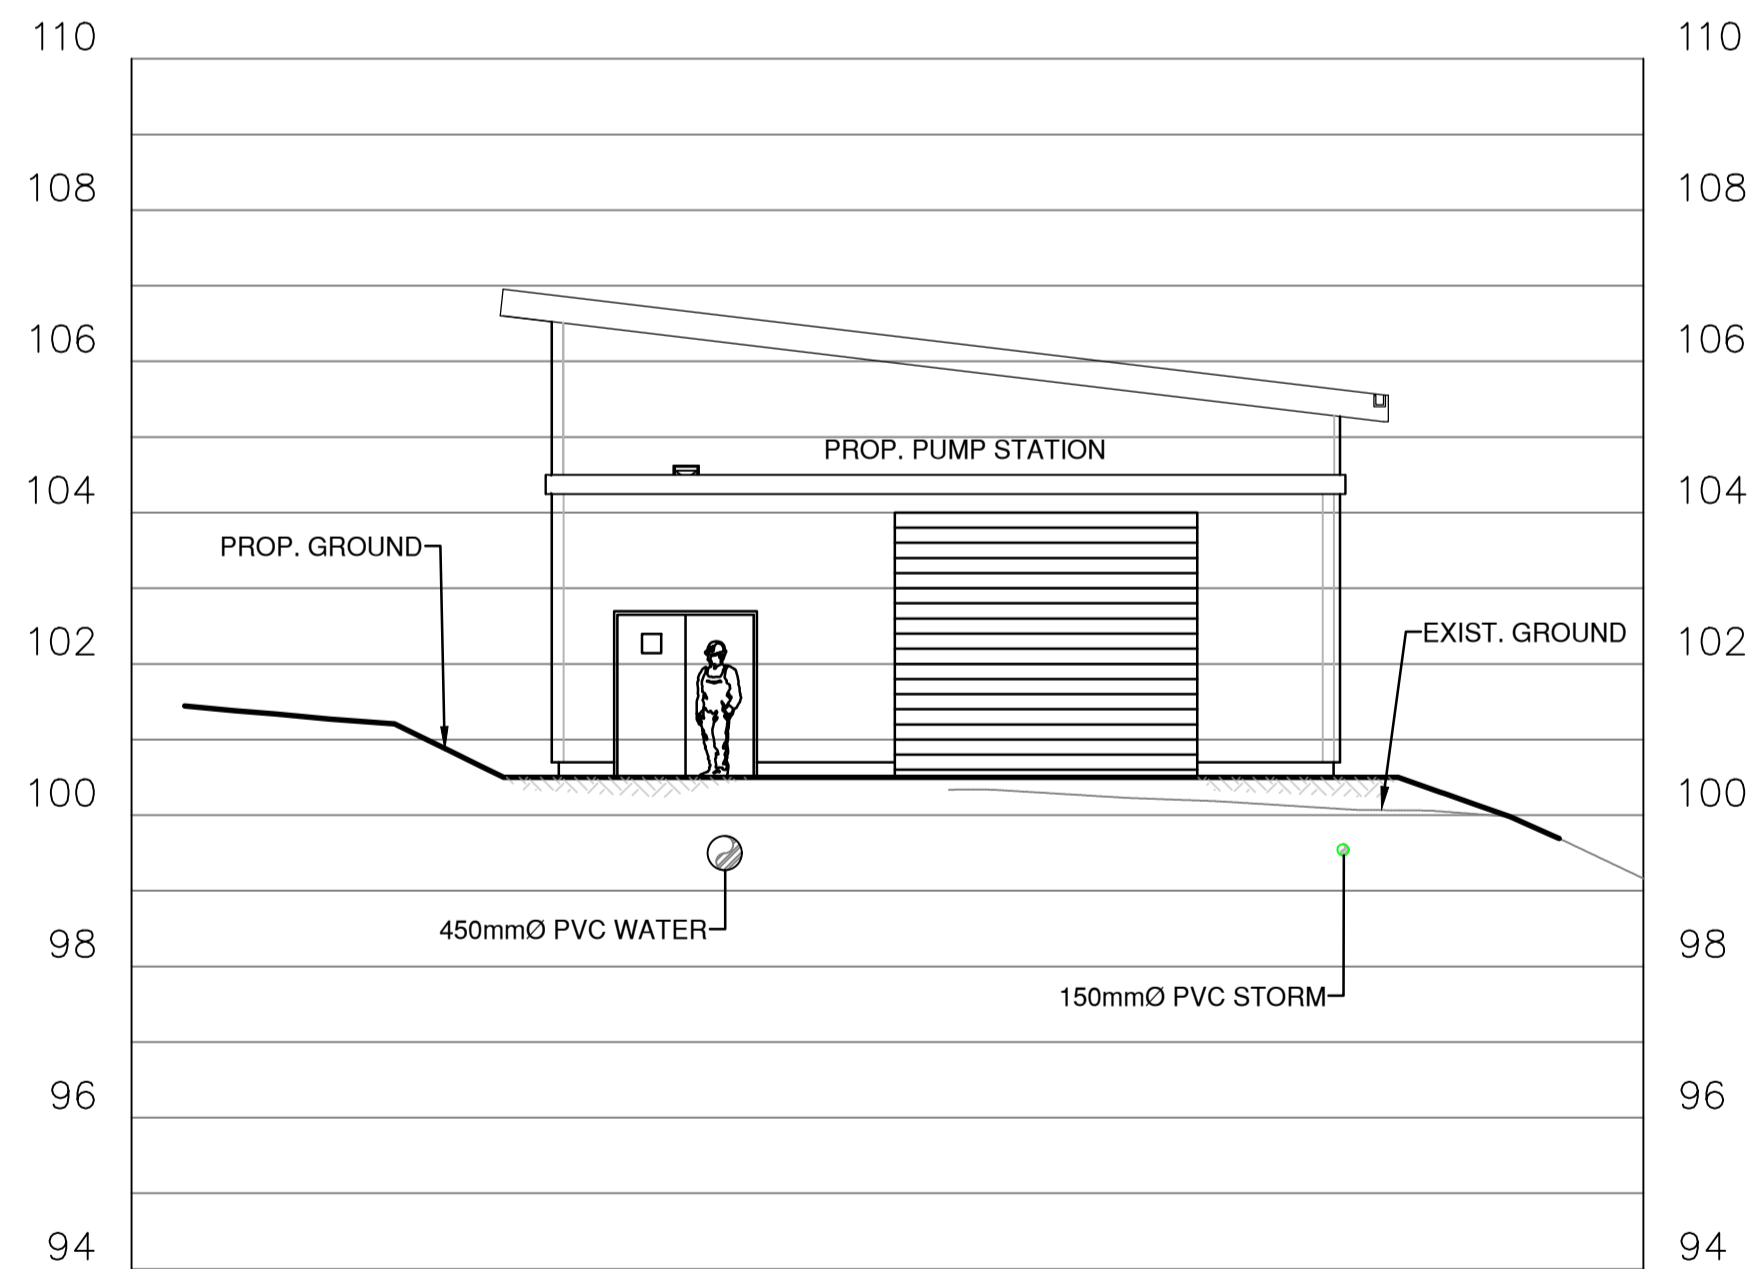

2 SECTION
C101 1:100



PLOT DATE: August 21, 2023 1:00:18 PM \\planning\shared_projects\1170076\110_drawings\02_sheets\01_civil\01_DWG\75%_DESIGN REVIEW\C102 - C104.dwg

NO.	DATE	REVISION	DRAWN	APPR'D
1	08-22-2023	ISSUED FOR 75% DESIGN REVIEW	MB	AH



4515 Central Blvd. # 500
Burnaby, BC Canada V5H 0C6
Tel: (604) 436-3014
www.stantec.com

The Contractor shall verify and be responsible for all dimensions. DO NOT scale the drawing.
Any errors or omissions shall be reported to Stantec without delay.
The Copyright to all designs and drawings are the property of Stantec. Reproduction or use
for any business other than that authorized by Stantec is prohibited.


DRAWN	MBB
DESIGNED	LP
CHECKED	CC
APPROVED	AH
SCALES	
HORZ.	1:100
VERT.	1:100

SEAL


NOT FOR CONSTRUCTION

Not for permits, pricing or other official purposes. This document has not been completed or checked and is for general information or comment only.

DISTRICT OF WEST VANCOUVER ENGINEERING DEPARTMENT	
SITE SECTIONS	
11TH STREET PUMP STATION REPLACEMENT #1075 MATHERS AVE WEST VANCOUVER, BC	
DATE	JULY 2023
SHEET	OF
DWG. No.	C104

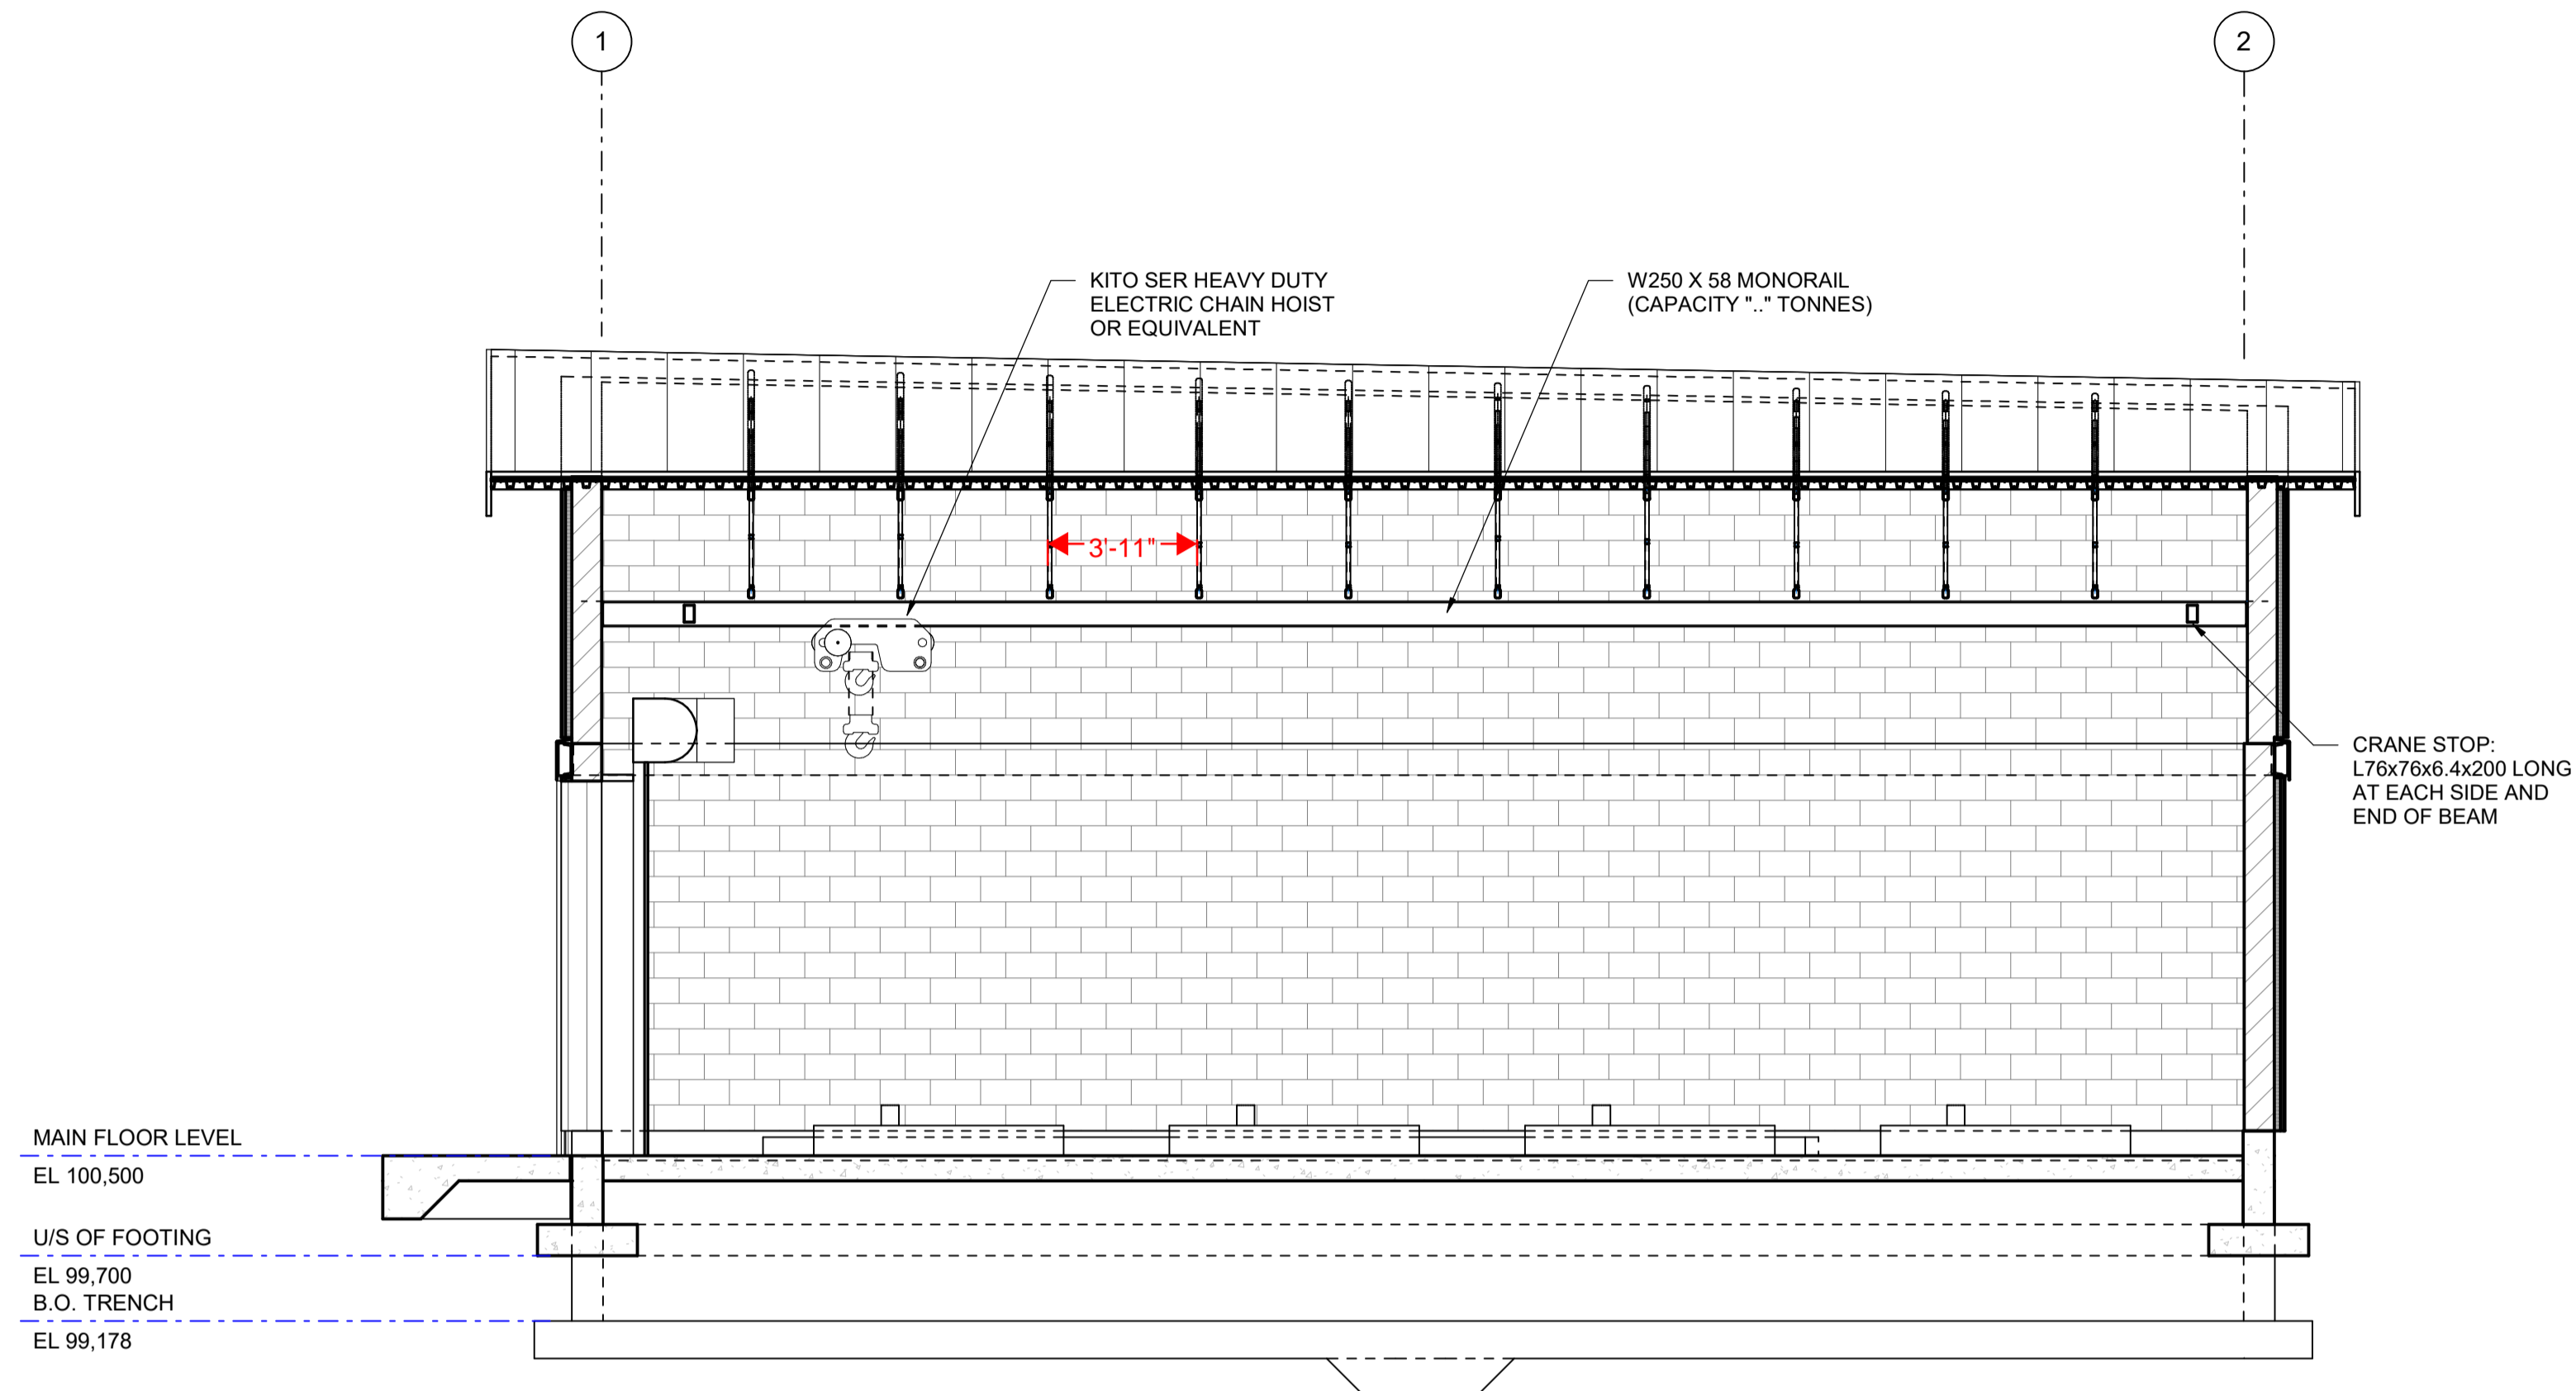

1 SECTION
S101 SCALE: 1 : 50

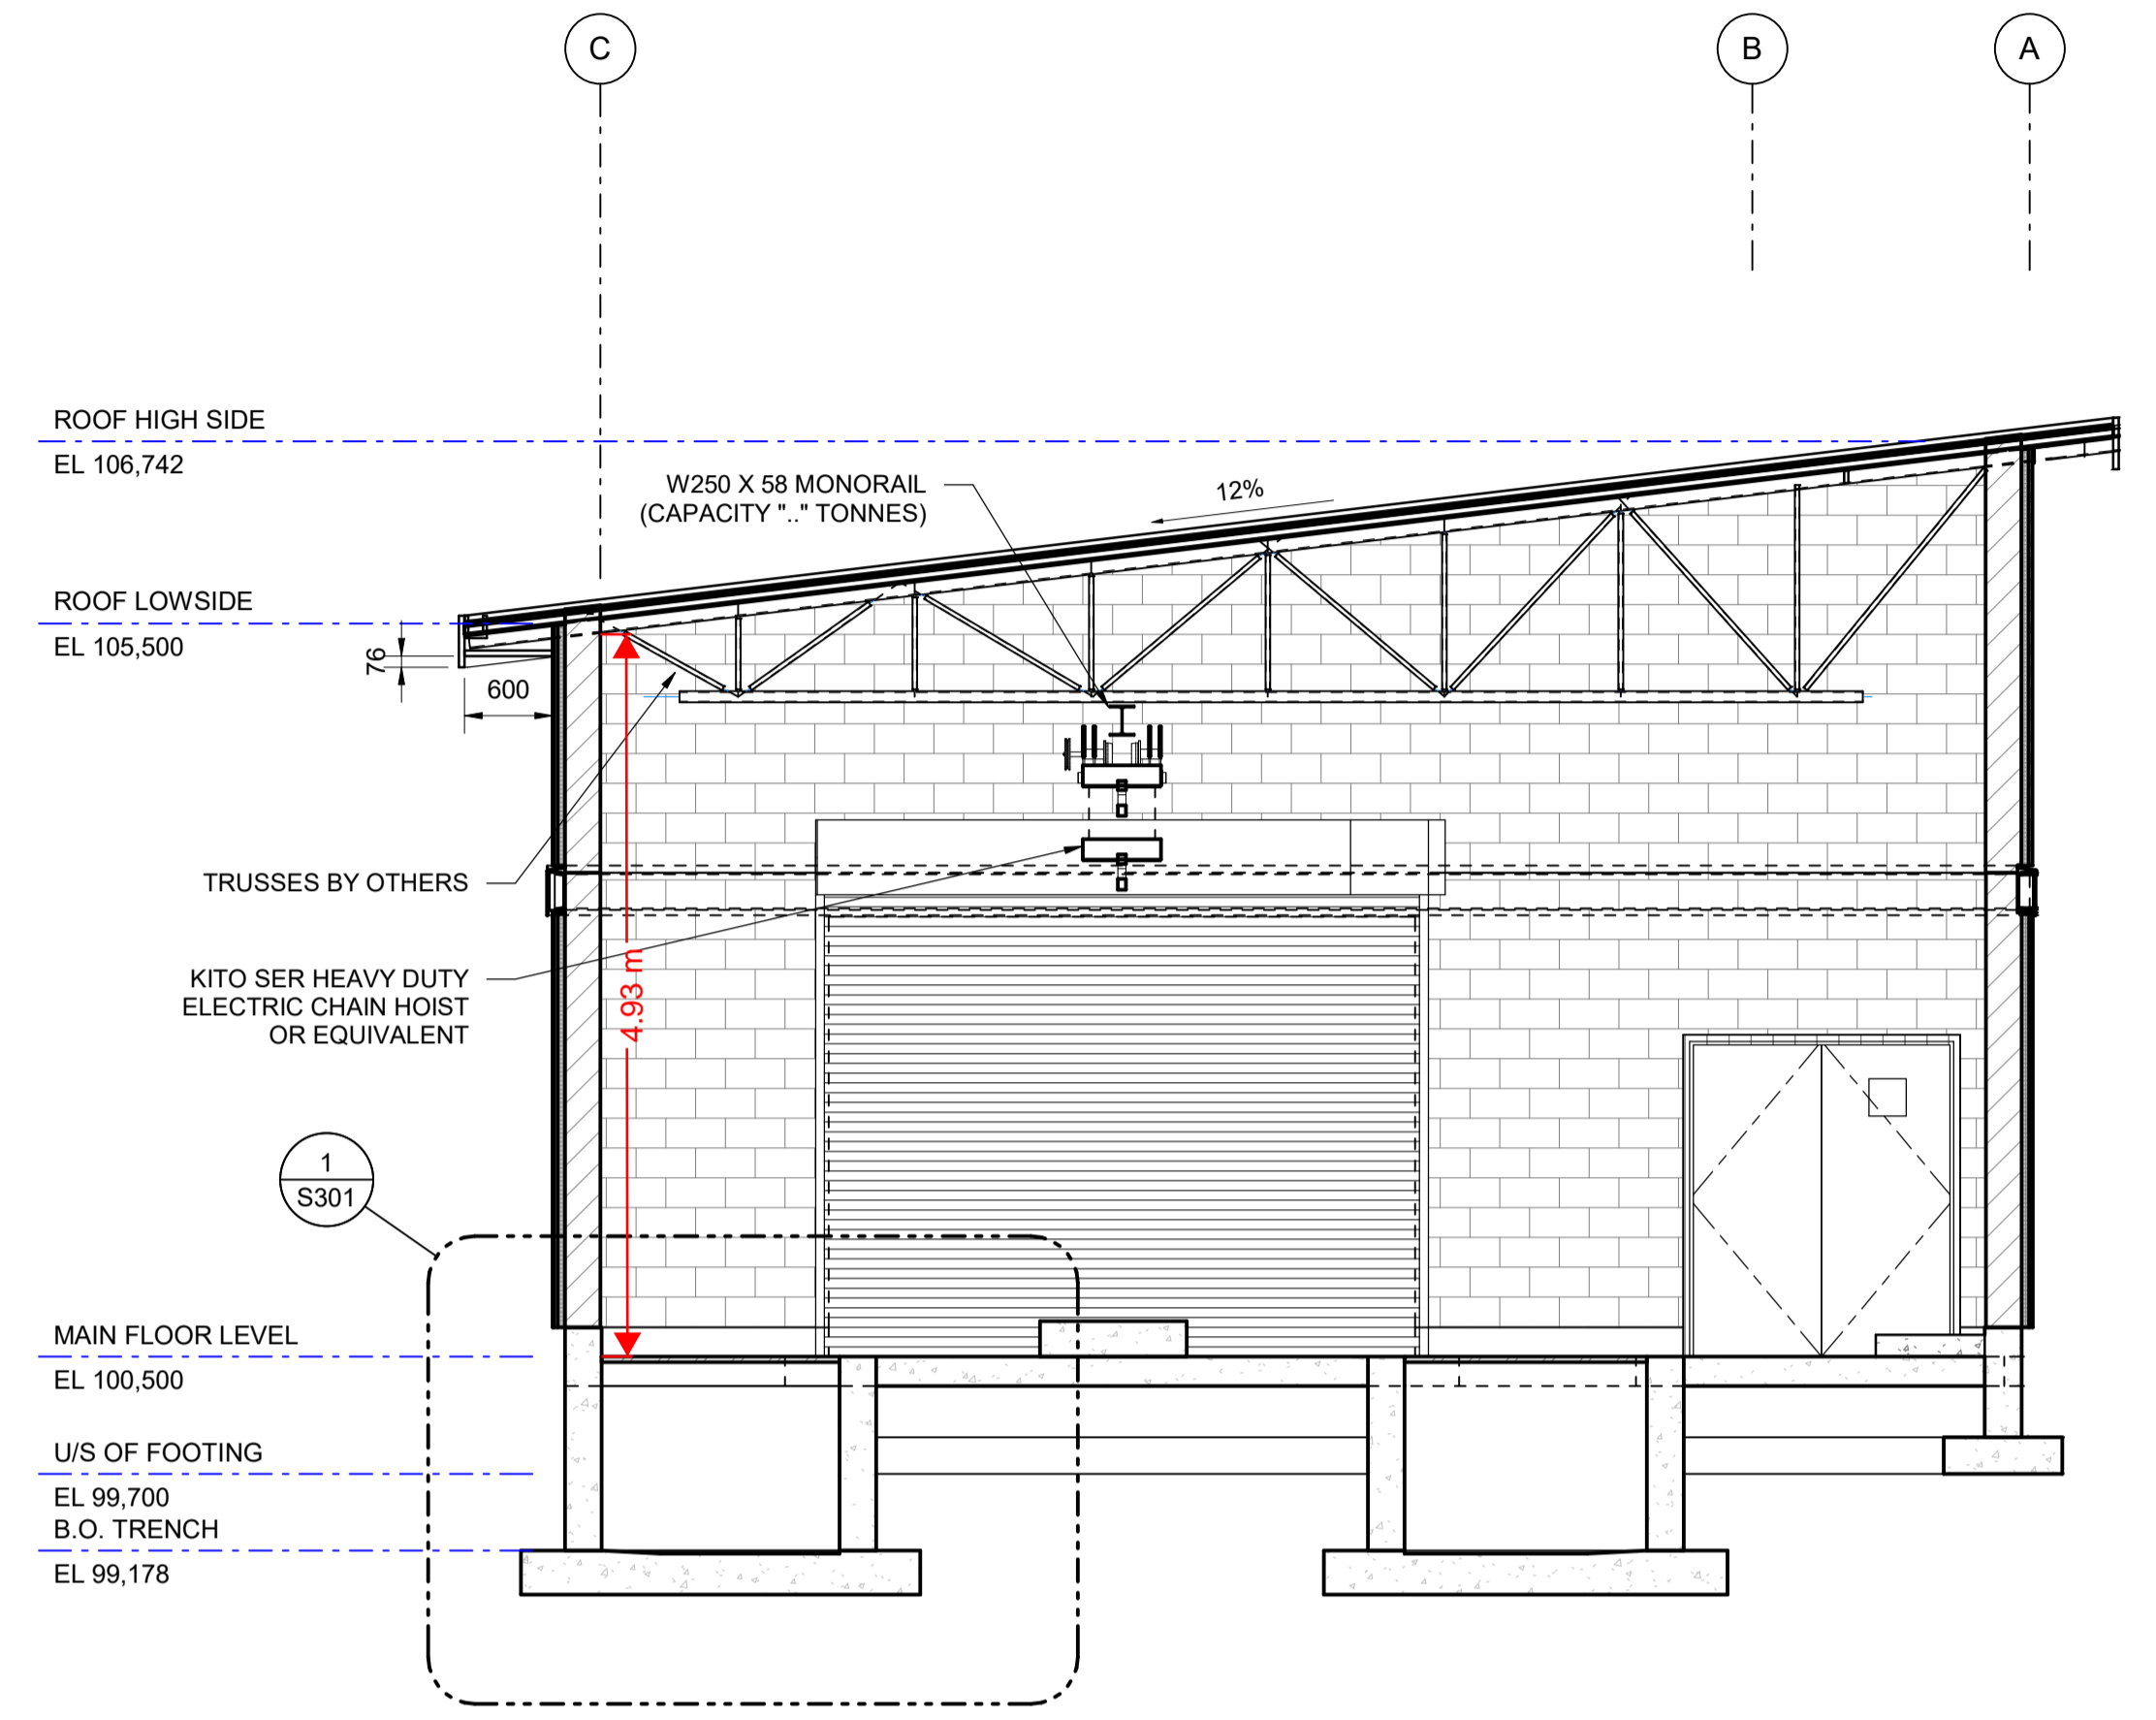

2 SECTION
S101 SCALE: 1 : 50

B:\1050\1115\0301_11th_Street_Pump_Station\00751505.dwg
 8/22/2023 11:52:20 AM

No.	DATE	REVISION	DRAWN	APPRD
1	08-01-23	ISSUED FOR 75% DESIGN	AY	VS



Stantec
 4515 Central Blvd., #500
 Burnaby, BC Canada V5H 0C6
 Tel: (604) 436-3014
 www.stantec.com
The Contractor shall verify and be responsible for all dimensions. DO NOT scale the drawing. Any errors or omissions shall be reported to Stantec without delay. The Copyrights to all designs and drawings are the property of Stantec. Reproduction or use for any purpose other than that authorized by Stantec is prohibited.


DRAWN	AY
DESIGNED	VS
CHECKED	VS
APPROVED	SG
SCALES	
HORZ.	1 : 50
VERT.	

NOT FOR CONSTRUCTION
Not for permits, pricing or other official purposes. This document has not been completed or checked and is for general information or comment only.

DIST OF WEST VANCOUVER
 ENGINEERING DEPARTMENT
STRUCTURAL - SECTIONS
 11TH STREET PUMP STATION REPLACEMENT
 #1075 MATHERS AVE WEST VANCOUVER, BC


DATE	JULY 2023
SHEET	OF
DWG. No.	S201

PLOT DATE: August 21, 2023 - C:\Users\steli\ACCD\steli\Projects\1170276\11_11th_Street_Pump_Station\Project\Files\Water Team\Folder_Structure\10_drawings\02_sheets\10_landscape\1_102 - Tree Management Plan_EL.dwg

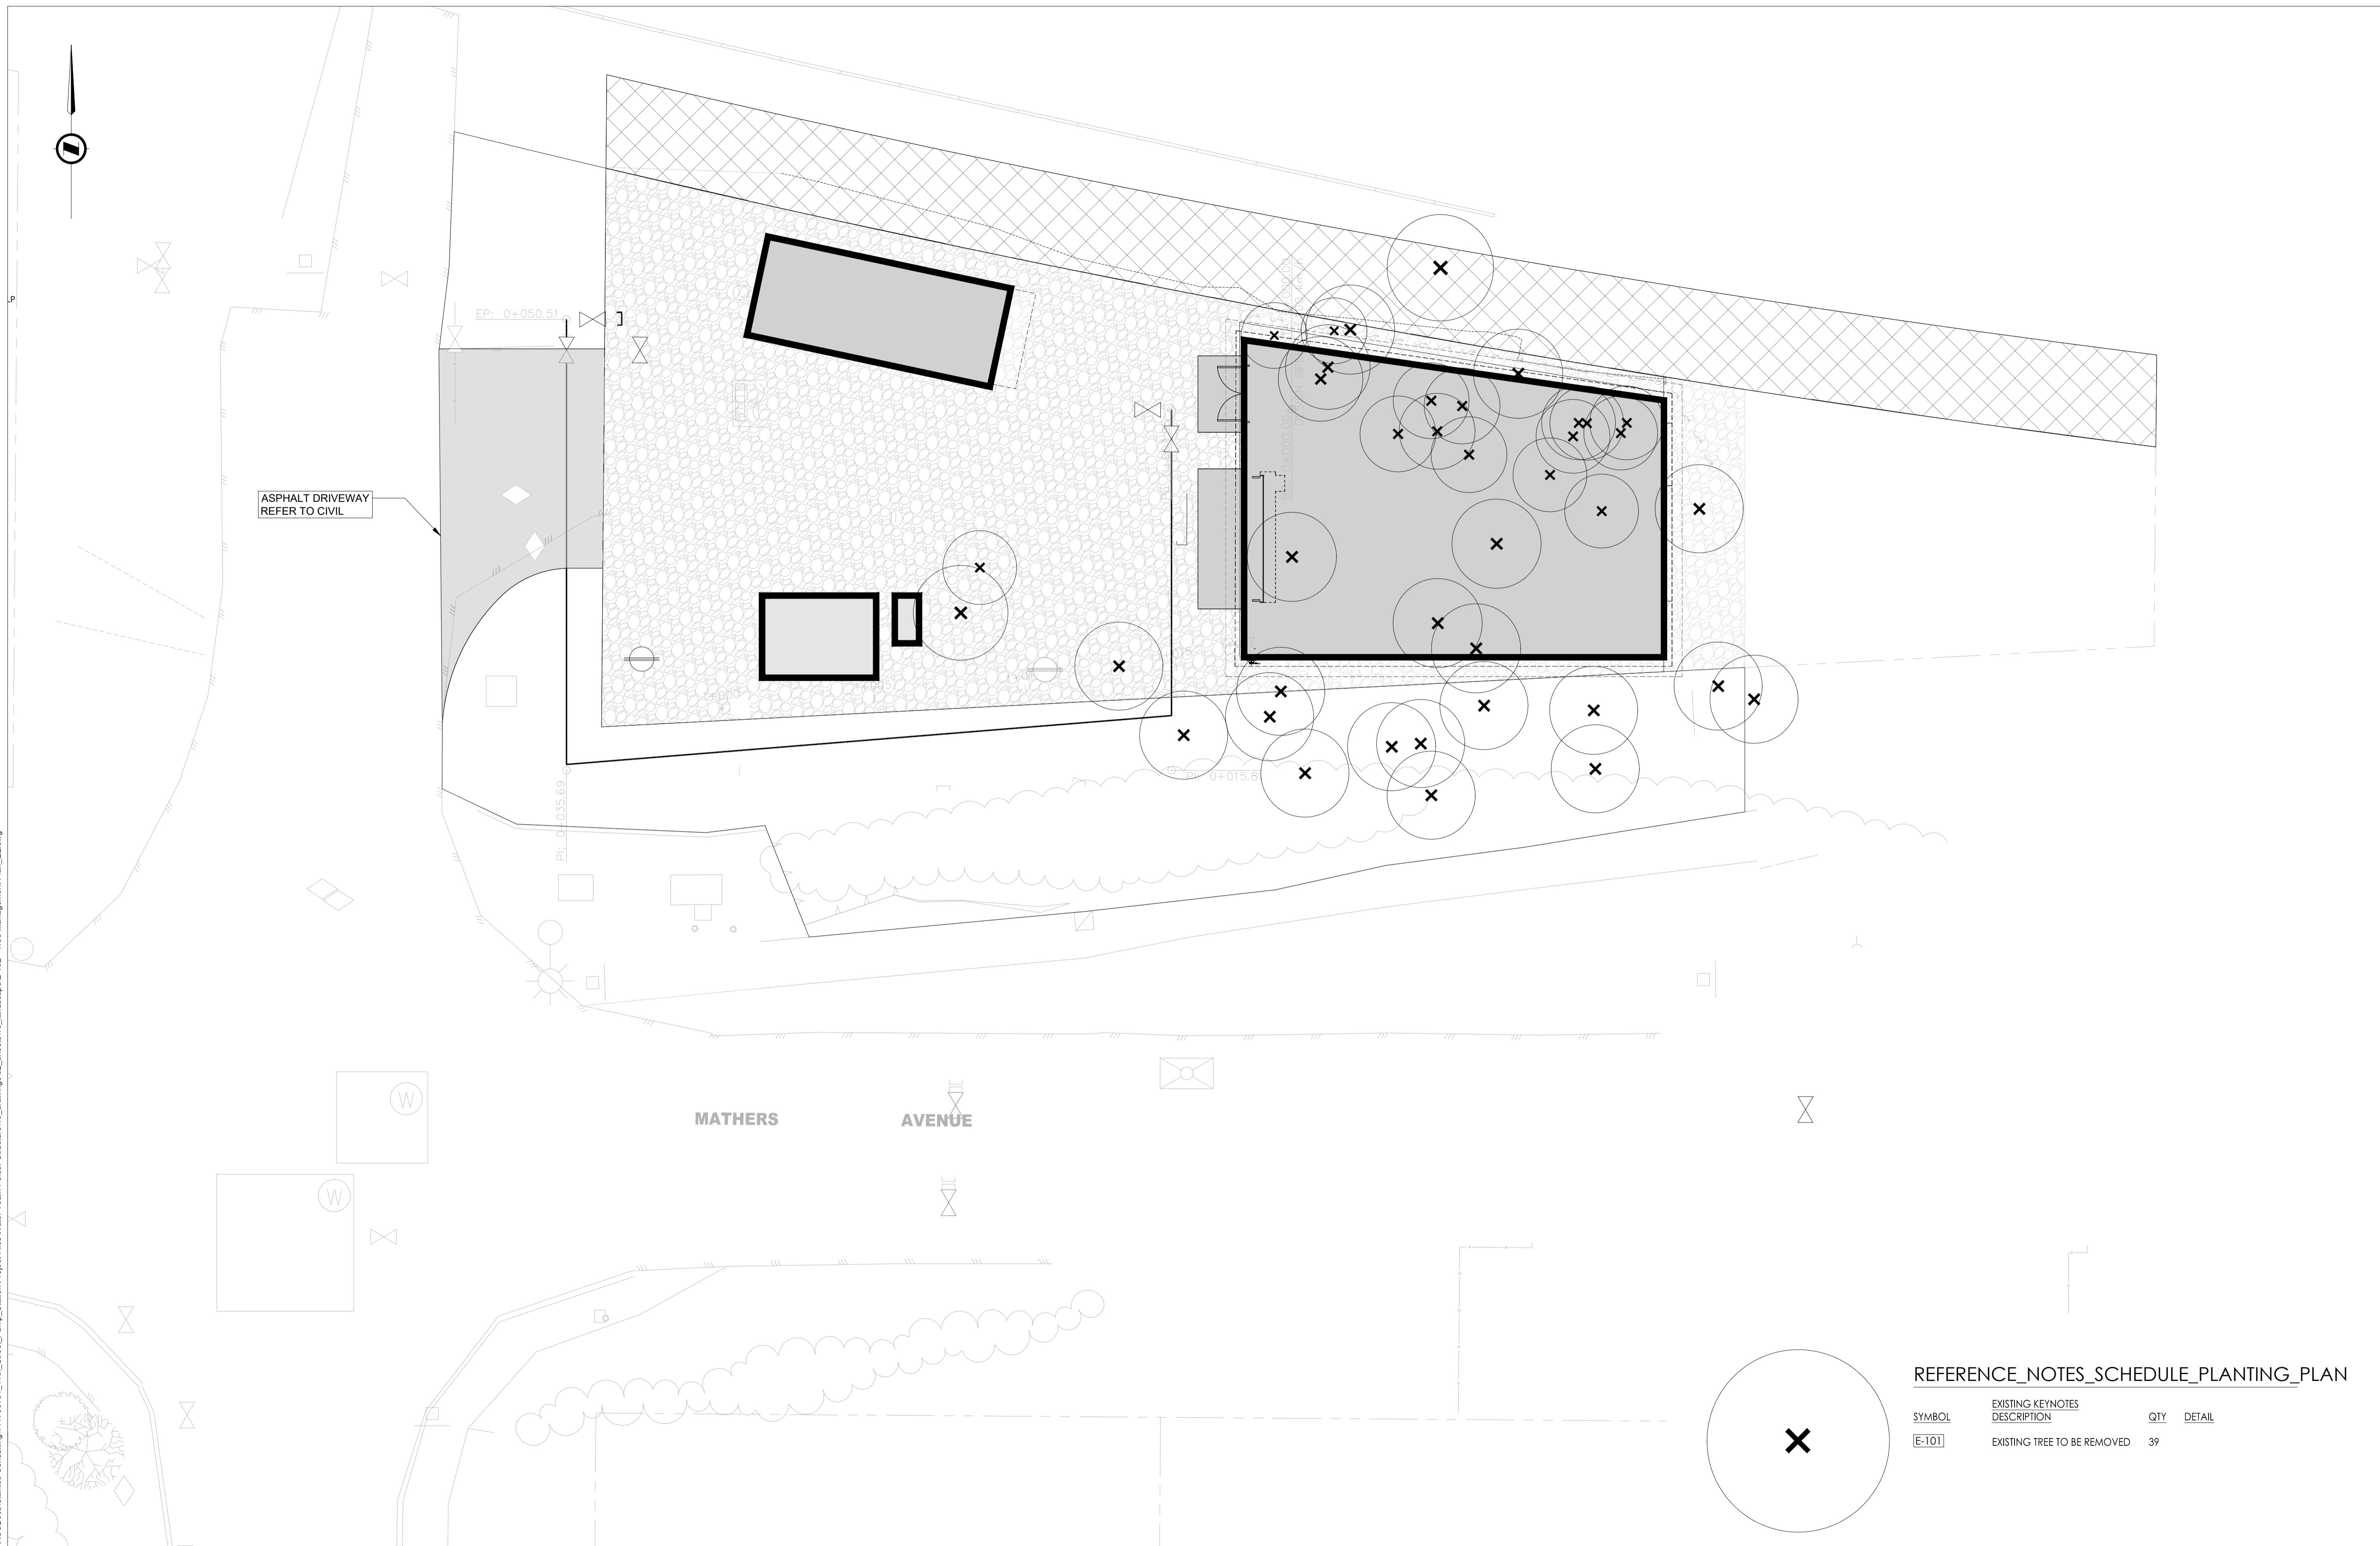

REFERENCE NOTES SCHEDULE PLANTING PLAN

SYMBOL	EXISTING KEYNOTES DESCRIPTION	QTY	DETAIL
E-101	EXISTING TREE TO BE REMOVED	39	

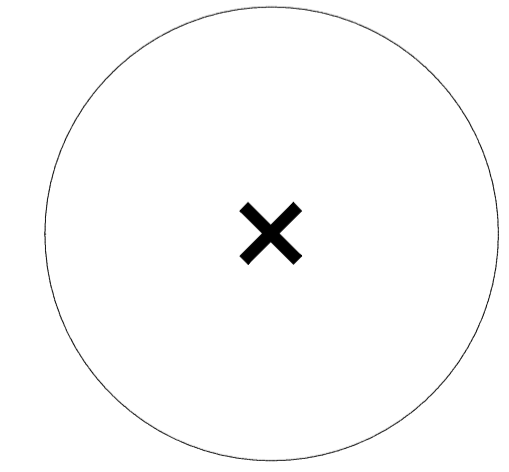

NO.	DATE	REVISION	DRAWN	APPR'D
1	08-22-2023	ISSUED FOR 75% DESIGN	EL	MG



Stantec
 4515 Central Blvd. #500
 Burnaby, BC Canada V5H 0C6
 Tel: (604) 436-3014
 www.stantec.com

The Contractor shall verify and be responsible for all dimensions. DO NOT scale the drawing. Any errors or omissions shall be reported to Stantec without delay. The Copyright to all designs and drawings are the property of Stantec. Reproduction or use for any purpose other than that authorized by Stantec is prohibited.

DRAWN	EL
DESIGNED	LM
CHECKED	MG
APPROVED	MG
SCALES	
HORZ.	1:500
VERT.	1:50

NOT FOR CONSTRUCTION


Not for permits, pricing or other official purposes. This document has not been completed or checked and is for general information or comment only.

DISTRICT OF WEST VANCOUVER
 ENGINEERING DEPARTMENT

TREE MANAGEMENT PLAN
 11TH STREET PUMP STATION REPLACEMENT
 #1075 MATHERS AVE WEST VANCOUVER, BC

DATE	AUGUST 2023
SHEET	OF
DWG. No.	L101

PLOT DATE: August 21, 2023 - C:\Users\steli\ACCD\Stantec Consulting\1170276_11th_Street_Pump_Station\Project Files\Water Team Folder - Structural\10_drawings\02_planting\02_planting\10_LANDSCAPE_EL.dwg

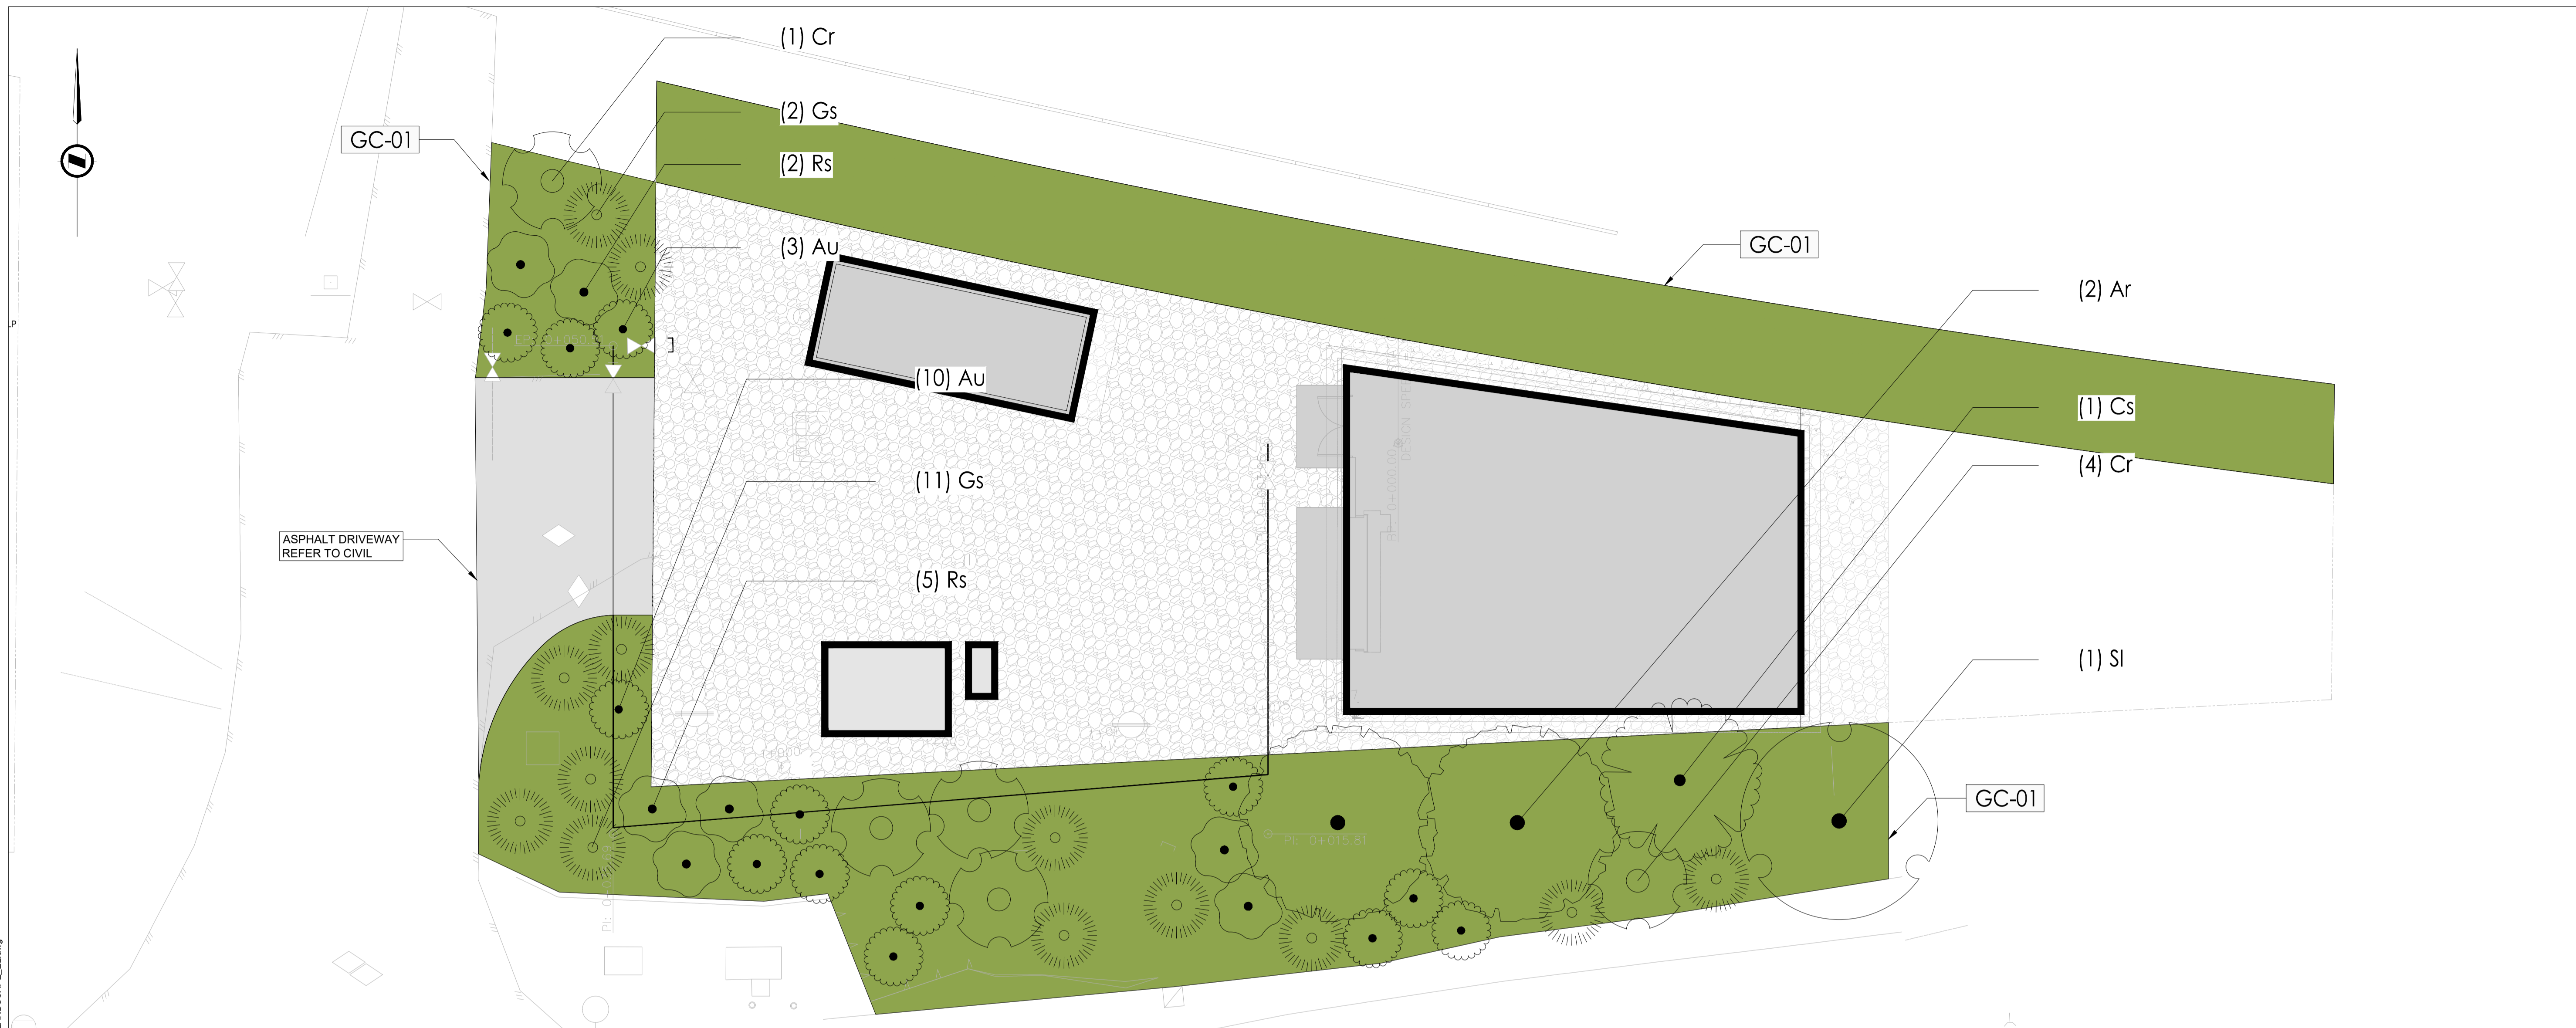

PLANT_SCHEDULE_PLANTING_PLAN

TREES	CODE	QTY	BOTANICAL / COMMON NAME	CAL/HT	SPACING
-------	------	-----	-------------------------	--------	---------

	Ar	2	ALNUS RUBRA / RED ALDER	70MM CAL.	
	Cs	1	CORNUS KOUSA / KOUSA DOGWOOD	70MM CAL.	
	Sl	1	SALIX LUCIDA / PACIFIC WILLOW	70MM CAL.	

SHRUBS	CODE	QTY	BOTANICAL / COMMON NAME	CONT
	Au	13	ARCTOSTAPHYLOS UVA-URSI / KINNIKINICK	#2 POT.
	Cr	5	CORNUS SERICEA / RED TWIG DOGWOOD	#2 POT.
	Gs	13	GAULTHERIA SHALLON / SALAL	#2 POT.
	Rs	7	RUBUS SPECTABILIS / SALMONBERRY	#2 POT.

REFERENCE_NOTES_SCHEDULE

SYMBOL	GROUND COVER DESCRIPTION	QTY	DETAIL
	GC-01	HYDROSEED	445.3 m ² L103/1

NO.	DATE	REVISION	DRAWN	APPR'D
1	08-22-2023	ISSUED FOR 75% DESIGN	EL	MG



Stantec
 4515 Central Blvd. #500
 Burnaby, BC Canada V5H 0C6
 Tel: (604) 436-3014
 www.stantec.com

DRAWN	EL
DESIGNED	LM
CHECKED	MG
APPROVED	MG
SCALES	
HORZ.	1:500
VERT.	1:50

NOT FOR CONSTRUCTION
 Not for permits, pricing or other official purposes. This document has not been completed or checked and is for general information or comment only.

DISTRICT OF WEST VANCOUVER
 ENGINEERING DEPARTMENT

PLANTING PLAN
 11TH STREET PUMP STATION REPLACEMENT
 #1075 MATHERS AVE WEST VANCOUVER, BC

DATE	AUGUST 2023
SHEET	OF
DWG. No.	L102